



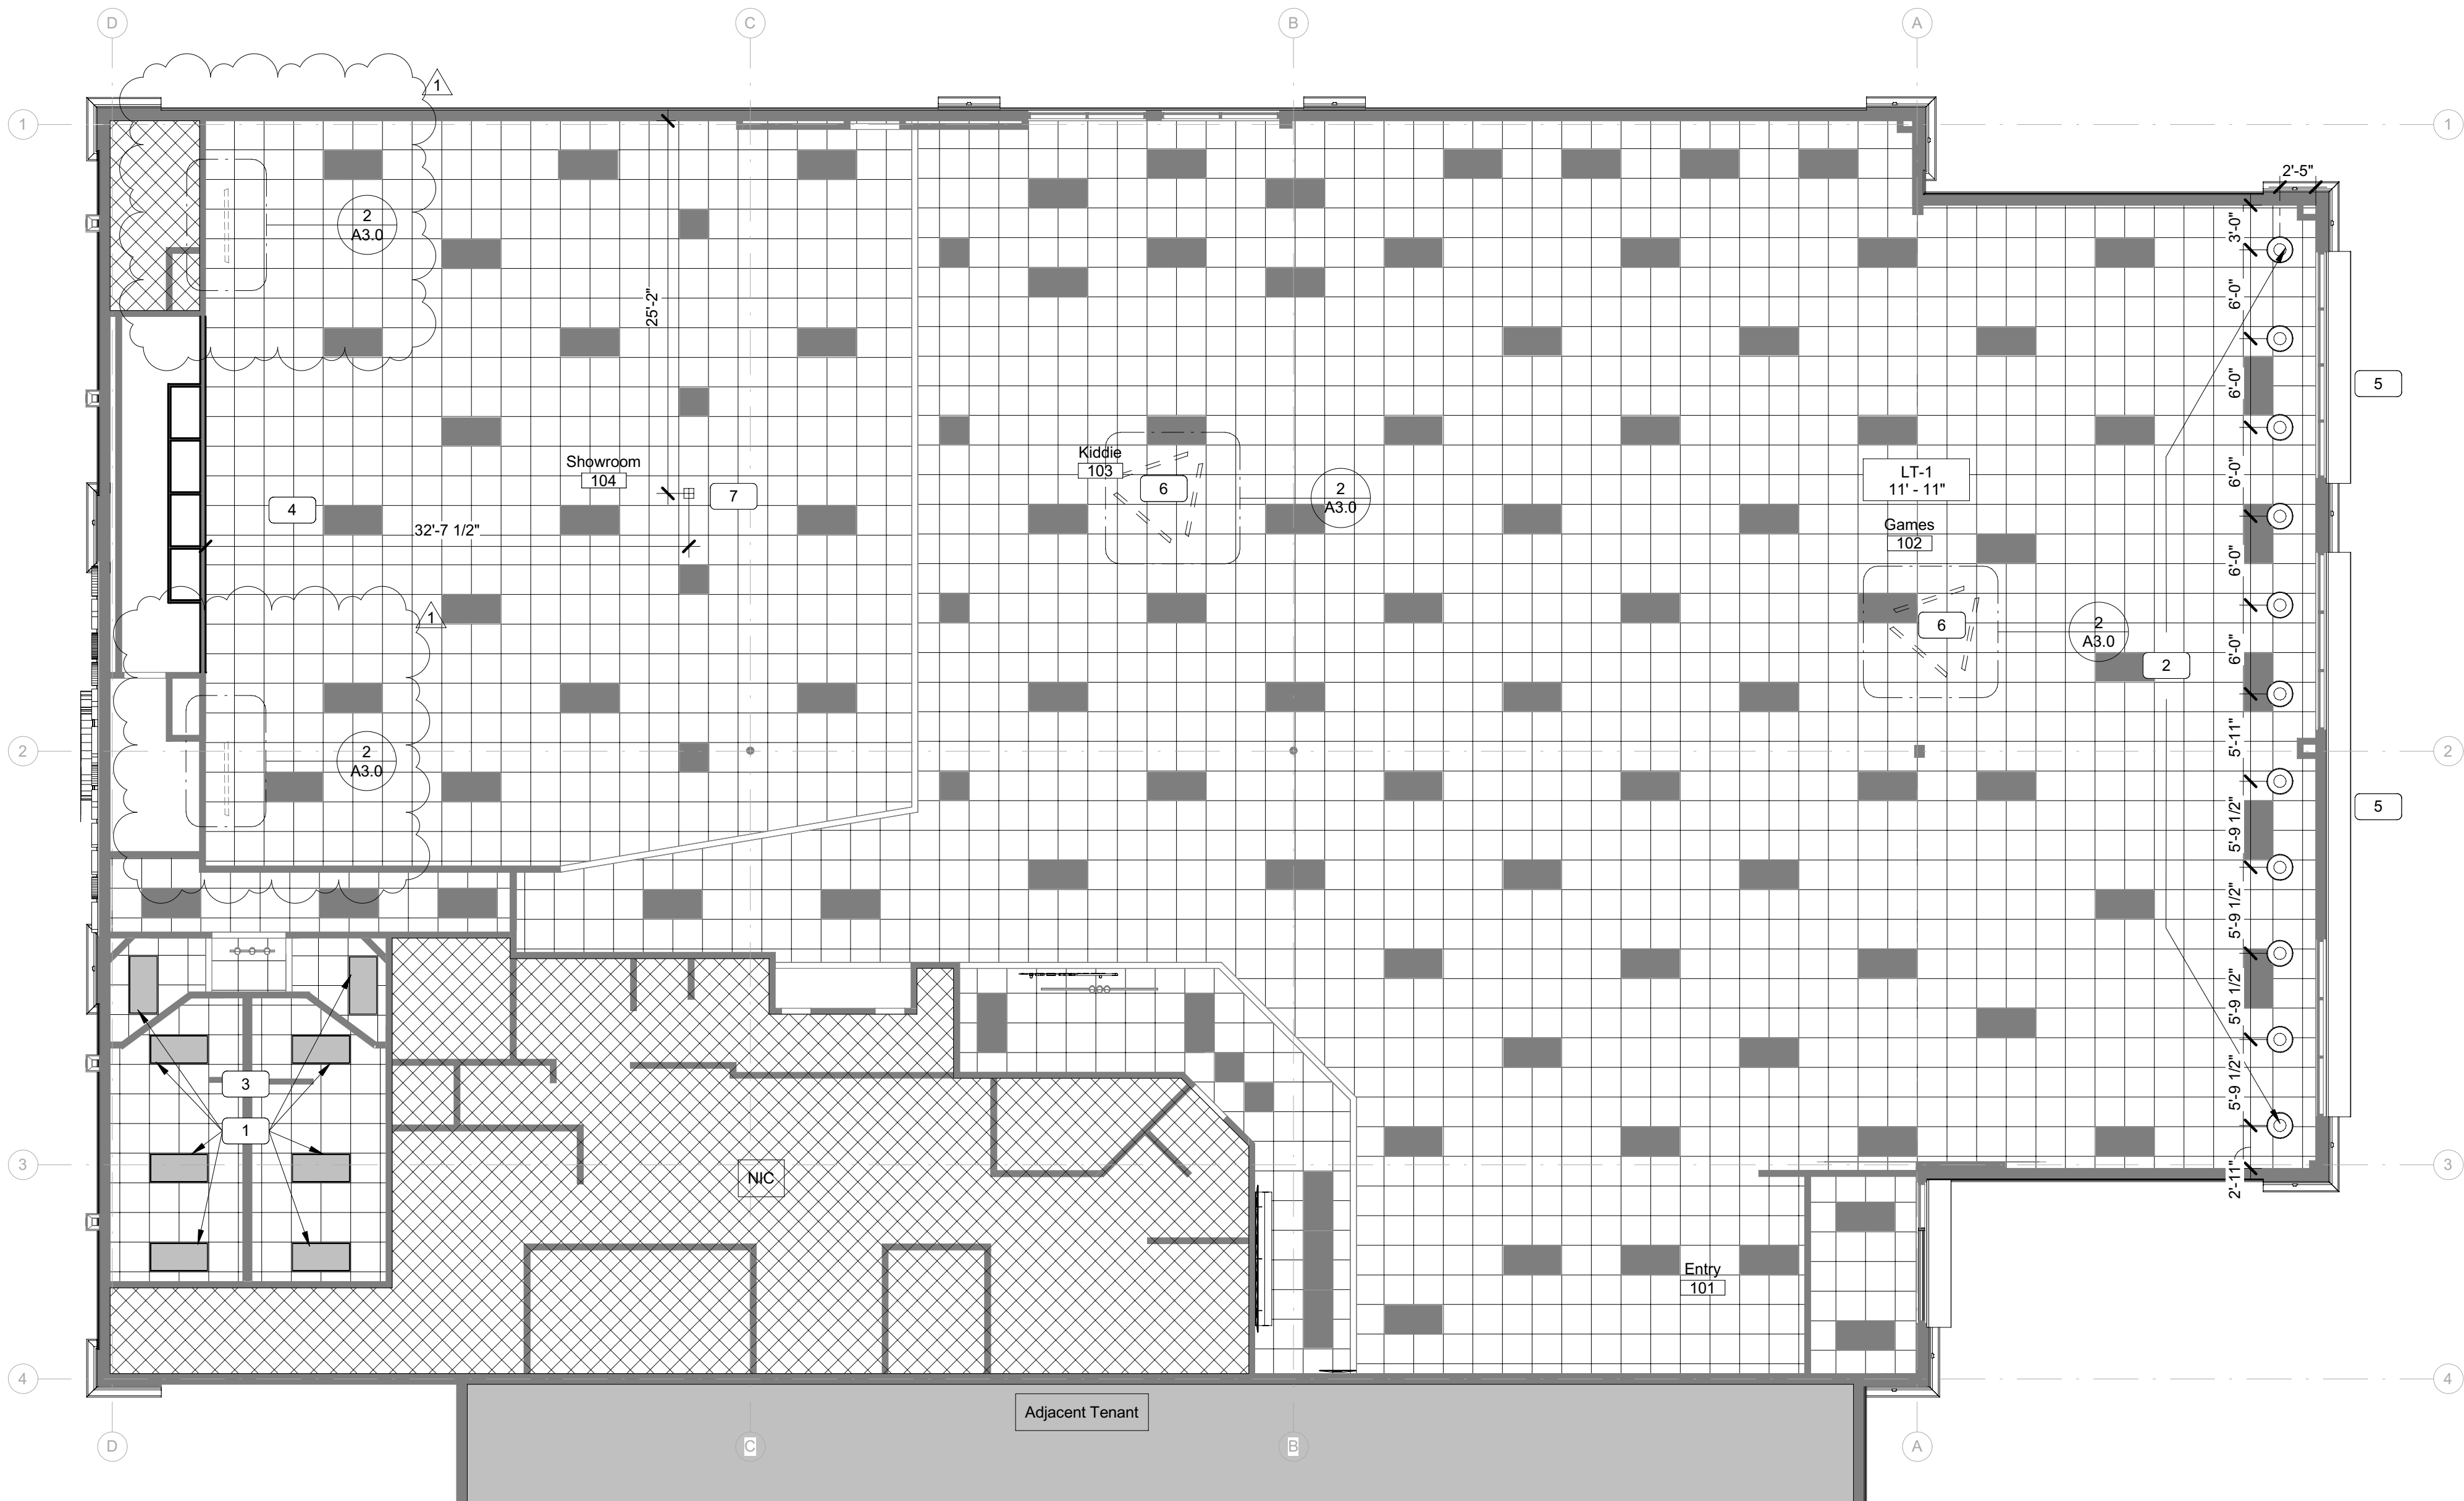

1 Reflected Ceiling Plan

1/8" = 1'-0"

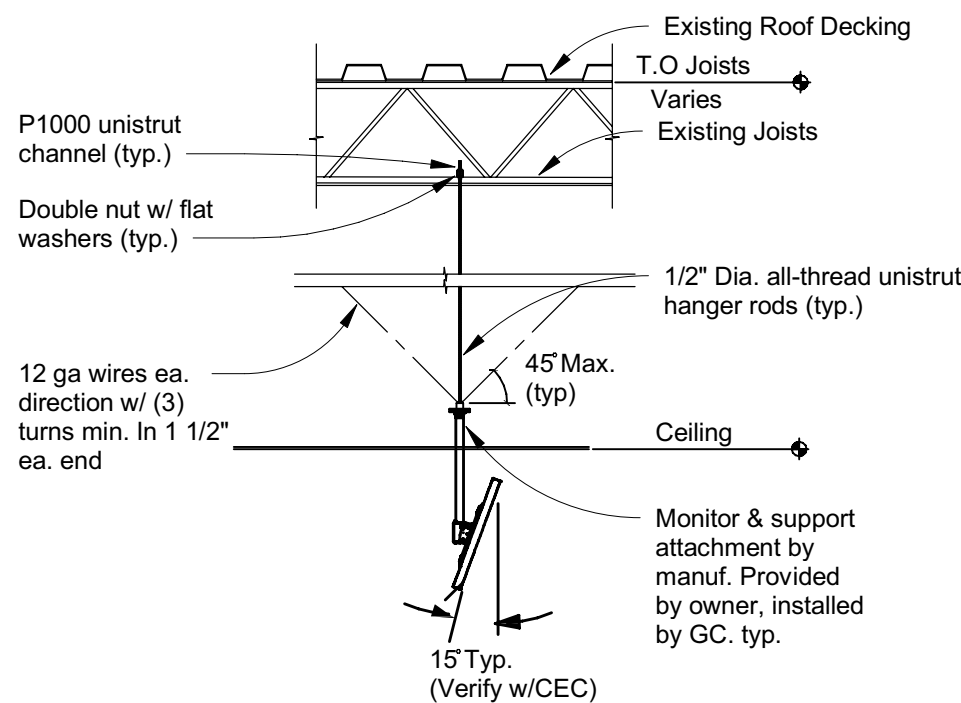

2 Monitor Frame section A

NTS

General Notes - RCP

- A All dimensions are to finish face.
- B Layout ceiling tile from center of room, both directions unless noted otherwise.
- C Sprinkler heads in suspended T-bar ceilings shall be centered in panels.
- D Ensure sprinkler head locations are clear of other ceiling fixtures and elements per plans
- E Coordinate all ductwork to avoid interference with ceiling support systems.
- F Light fixtures and HVAC diffusers shown on this drawing are for location and coordination purposes.
- G No fixtures, grilles, speakers, sprinkler heads, etc. shall touch the ceiling T's or shadow line; Center in panel.
- H Paint all grilles and recessed speakers to match ceiling grid.
- I All speakers wire shall home run to control room rack. Ref. AVI sheet for connections.
- J Exit Signage to be installed per OSSC 1011.
- K Ceiling grid installation shall be per section 9.6 of ASCE 7-02 and CISCA guidelines for Seismic zones 3-4.
- L Refer to detail for Typical light bracing requirements.
- M GC to field verify all existing light and mechanical fixtures.
- N GC is responsible for coordination and verification of power for signage/awning prior to installation.
- O All non-rated partition to terminate 6" above finish ceiling. See wall types, drawings for additional information.
- P Coordinate all mechanical, electrical, and fire protection systems that are supported by interface w/ceiling systems.
- Q All insulation wiring and other construction items shall be non-combustible and rated as required by code for work in plenum spaces where indicated.
- R Replace damaged ceiling tiles up to 1,700sf; Paint ceiling grid to match existing as needed, typ.
- S Verify all exterior soffitt lights are in working order and color temperatures match. Repair/replace as needed. Paint underside of soffitt to match existing.

Legend - Reflected Ceiling Plan

- Existing Acoustical lay-in ceiling LT-1
- Existing Acoustical lay-in ceiling LT-2
- Gypsum ceiling
- Ceiling Tag
 - Ceiling Finish Code
 - Ceiling Height (A.F.F.)
- LT-1 9'-0"
- 24" x 48" Troffer
- Recessed Can Light
- Vanity Light - 7'-0" AFF
- Pendant - 6'-0" AFF
- Exterior Wall Sconce
- 48" Industrial Fluorescent Strip
- Wall mount Television
- Exit Sign
- Supply Diffuser (Ref. Mechanical)
- Return Diffuser (Ref. Mechanical)
- Access Panel

Scope Notes - RCP

- 1 New 2x4 troffer light.
- 2 Install (11) pendant lights 6'-0" AFF, center on new tables.
- 3 Install vanity light 7'-0" AFF.
- 4 Remove or relocate track lights as needed to illuminate wall art typical.
- 5 LED strip lights at canopy
- 6 Ceiling mounted monitor in games area. Adjust electric and data as indicated. Terminations by CEC, data runs with slack to floor +15'. CEC to verify final location.
- 7 Power and data in ceiling centered over dance floor.



#055

8225 Kingston Pike
Knoxville, TN 37919

Owner:

CEC ENTERTAINMENT, INC.
1707 Market Place Blvd. Suite 200
Irving, TX 77063
Ph: 972-258-5521
Contact: Walter Boyd

Architect:

Parkway C&A, LP
1000 Civic Circle
Lewisville, TX 75287
Ph: 972-221-1979
Contact: Michael Orr

MEP Engineer:

Dialectic Engineering
310 W 20th Street 200
Kansas City, MO 64108
Ph: (816)997-9627
Contact: Joe Hillebrenner, P.E.

Design Directive: 43



Architect: William D. Pounds, Jr.

No.	Description	Date
1	City comments	2021.12.22
A	Permit Set	2021.10.18

DRAWN BY: CH

CHECKED BY: VG

PROJ. NO: 04-21829

Parkway C&A, LP © 2021

Reflected Ceiling Plan

