


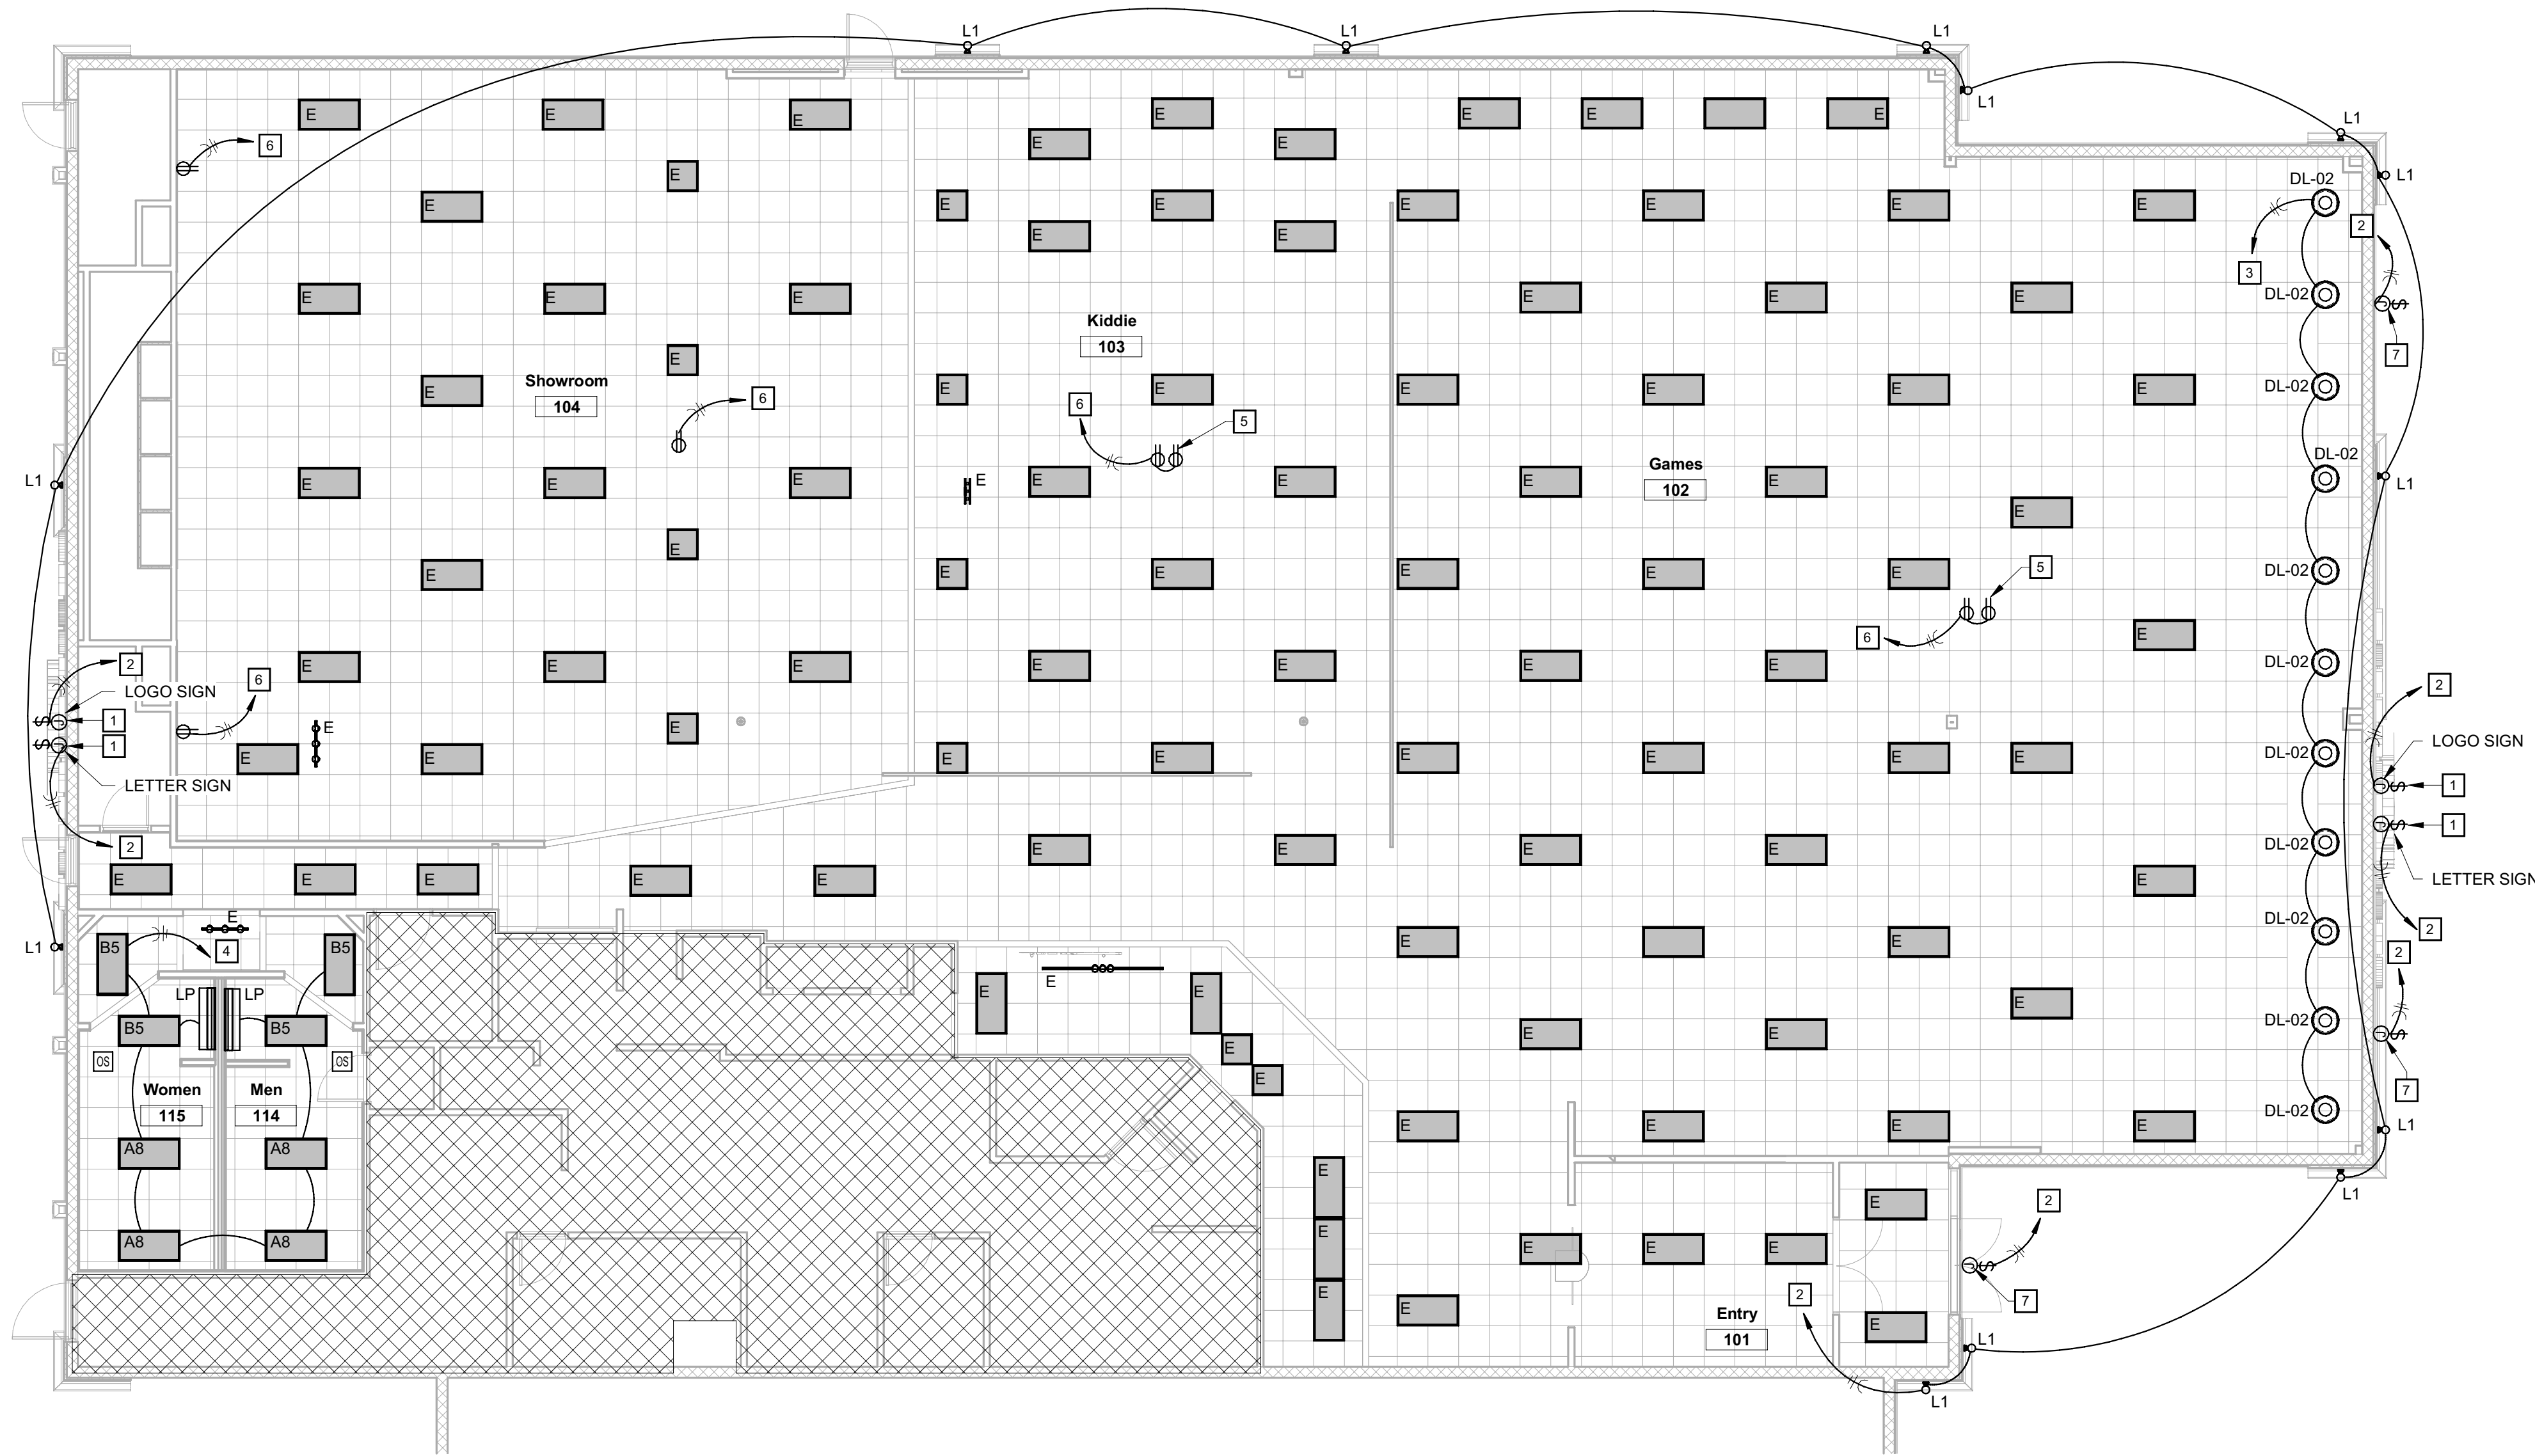

1 LIGHTING FLOOR PLAN

1/8" = 1'-0"



LIGHTING FIXTURE SCHEDULE							
Type Mark	MANUFACTURER	CATALOG NUMBER	DESCRIPTION	LAMPS	VOLTS	FIXTURE WATTS	REMARKS
A8	COMMERCIAL LIGHTING IND.	CLI-CECNAAB	2X4 FLOURESCENT - DIRECT/INDIRECT TROFFER - 3 LAMPS	F032/T8/841	120 V	84 VA	
B5	COMMERCIAL LIGHTING IND.	CLI-CECNABS	2X4 FLOURESCENT - W/ BATTERY BACK-UP	F032/T8/841	120 V	32 VA	
DL-02	COMMERCIAL LIGHTING IND.	CLI-CECNADL-02	FLY SUSPENSION LAMP COLOR: ORANGE; DIM 20.5"D X 13"H; 101" MAX HEIGHT	E26 MEDIUM BASE HALOGEN MAP	120 V	43 VA	MOUNT AT 6' AFF.
L1	COMERCIAL LIGHTING IND.	CLI-CECNADL-01	EXTERIOR WALL SCONCE LED TUBE DOWN OUTDOOR WALL LIGHT. COLOR: BLACK; DIM. 5L X 7H X 6" EXTENSION	LED LAMP INCLUDED	120 V	18 VA	LABELED FOR WET LOCATION
LP	COMMERCIAL LIGHTING IND.	CLI-CECNALP-22	4'-0" LONG VANITY LIGHT OVER RESTROOM LAVATORIES	F032/T8/841	120 V	32 VA	MOUNT AT 7'-0" AFF CENTERLINE OF FIXTURE

LIGHTING GENERAL NOTES

- CONNECT EXIT SIGNS, EMERGENCY AND NIGHT LIGHTS TO AN UNSWITCHED LIGHTING CIRCUIT. NOT CONTROLLED BY ANY OCCUPANCY SENSORS, SWITCHES OR CONTACTORS.
- OUTLETS, SWITCHES, AND PLATES SHALL BE:
A) STAINLESS AT FRP
B) GREY AT MARLITE. SAFETY RECEPTACLES, LEVITON 5262-SGG RECEPTACLES, 80703 EG PLATE.
C) WHITE AT ALL OTHER AREAS.
D) CEILING OUTLET SHALL BE PAINTED TO MATCH CEILING COLOR.
- PROVIDE A DEDICATED NEUTRAL WITH ALL DIMMING SYSTEM CIRCUITS. NO COMMON NEUTRALS SHALL BE ALLOWED.
- REFER TO ARCHITECTURAL REFLECTED CEILING PLAN AND DETAILS FOR THE LOCATION OF ALL LIGHTING FIXTURES AND ALL OTHER EQUIPMENT INSTALLED IN THE CEILING SYSTEM. VERIFY MOUNTING HEIGHTS AND FINISHES WITH ARCHITECT PRIOR TO ROUGH-IN.
- REFER TO THE POWER PLANS FOR LOCATIONS OF ELECTRICAL EQUIPMENT

ELECTRICAL KEYNOTES

- PROVIDE JUNCTION BOX FOR SIGNAGE TRANSFORMER WITH CODE REQUIRED DISCONNECT. MOUNTED 24" ABOVE FINISHED ROOF. COORDINATE FINAL LOCATIONS AND REQUIREMENTS WITH SIGNAGE VENDOR PRIOR TO ROUGH-IN. ALL TRANSFORMERS SHALL BE GROUNDED TO JUNCTION BOX. ROUTE CIRCUIT THROUGH PARAPET WALL. DO NOT PENETRATE ROOF.
- CIRCUIT SHALL BE CONTROLLED THRU EXISTING CONTACTOR ACTIVATED BY PHOTOCELL MOUNTED ON A ROOF AND DEACTIVATED BY A TIME CLOCK.
- CONNECT TO EXISTING SPARE LIGHTING BRANCH CIRCUIT. ROUTE THRU SPARE LIGHTING CONTROL SYSTEM CHANNEL. PROVIDE CONTACTOR IF EXISTING SPARE IS NOT AVAILABLE. CONTRACTOR SHALL VERIFY THE LOAD ON THE BRANCH CIRCUIT WHEN COMPLETE AND REPORT FINDINGS TO THE CEC PM IN WRITING.
- CONNECT TO AND REUSE THE EXISTING BRANCH CIRCUIT AND CONTROLS, PROVIDE OCCUPANCY SENSOR FOR RESTROOMS. EC TO VERIFY CIRCUITS ARE NOT OVERLOADED.
- RECEPTACLE AND DATA FOR TV MONITORS SUSPENDED FROM STRUCTURE.
- CONNECT TO EXISTING SPARE CIRCUIT. IF NO SPARE CIRCUITS ARE AVAILABLE, PROVIDE A 20A CIRCUIT BREAKER MATCHING EXISTING EQUIPMENT.
- WEATHER PROOF JUNCTION BOX FOR CONNECTIONS TO EYEBROW FEATURE LIGHT FIXTURES. VERIFY EXACT LOCATION. COORDINATE WITH SIGN MANUFACTURER.



#055

8225 Kingston Pike
Knoxville, TN 37919

Owner:

CEC ENTERTAINMENT, INC.
1707 Market Place Blvd. Suite 200
Irving, TX 77063
Ph: 972-258-5521
Contact: Walter Boyd


Architect:

Parkway C&A, LP
1000 Civic Circle
Lewisville, TX 75067
Ph: 972-221-1979
Contact: Don Daniels

MEP Engineer:

Dialectic Engineering
310 W 20th Street 200
Kansas City, MO 64108
Ph: (816)997-9627
Contact: Joe Hillebrenner, P.E.

Design Directive: 43

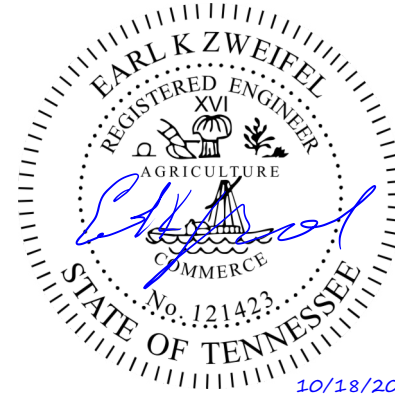

A	Permit Set	2021.10.18
No.	Description	Date

DRAWN BY: JGM

CHECKED BY: ATF

PROJ. NO: 04-XXXXX

Copyright Parkway C&A, LP 2021 ©

LIGHTING FLOOR PLAN



THIS SHEET IS PART OF THE CONSTRUCTION DOCUMENTS. DRAWINGS, SPECIFICATIONS AND OTHER SHEETS APPLY AND NEED TO BE REVIEWED IN TOTAL. ITEMS SHOWN ARE FOR DIAGRAMMATIC REPRESENTATION AND MAY NOT BE RELIED ON OR USED AS SHOP DRAWINGS. PROVIDE ALL MODIFICATIONS REQUIRED TO CONFORM TO SITE CONDITIONS, EQUIPMENT AND MATERIAL USED. VERIFY LOCATIONS AND DIMENSIONS OF ALL ARCHITECTURAL AND STRUCTURAL ELEMENTS PER THEIR RESPECTIVE DOCUMENTS, AS THESE ELEMENTS ARE SHOWN ONLY FOR REFERENCE, AND REQUIRE VERIFICATION PRIOR TO FABRICATION OR CONSTRUCTION. ENGINEER HAS NO LIABILITY FOR THE ACCURACY OF THESE ASSOCIATED ELEMENTS, OR FOR ANY WORK THE ENGINEER HAS NOT SIGNED AND SEALED.



Dialectic, Inc.
310 W 20th Street, Suite 200
Kansas City, MO 64108

Tennessee Certificate of
Authorization Number 3171

T 816-997-9601
F 816-997-9602
DialecticEng.com

Copyright 2021